

**立法會**  
**Legislative Council**

LC Paper No. PWSC79/05-06

Ref : CB1/F/2/5

Tel : 2509 4602

Date : 13 June 2006

From : Clerk to the Public Works Subcommittee

To : Members of the Public Works Subcommittee


---

**Public Works Subcommittee**

**Supplementary information on  
127BF – Fire Services Department diving training centre in the  
Government Dockyard at Stonecutters Island**

At the Public Works Subcommittee (PWSC) meeting on 29 May 2006 when members considered the paper PWSC(2006-07)16 on the above item, the Administration was requested to provide two-dimensional and/or cross-sectional plans on the facilities provided in the proposed diving training centre. A written response from the Administration is attached.

2. The recommendation of PWSC on the item will be considered by the Finance Committee at its meeting on 23 June 2006.

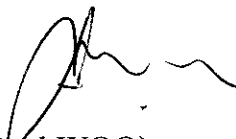

(Paul WOO)

Clerk to the Public Works Subcommittee

Encl.

c.c. Other members of the Finance Committee

政府總部  
香港下亞厘畢道



GOVERNMENT SECRETARIAT  
LOWER ALBERT ROAD  
HONG KONG

本函檔號 OUR REF.: SF(3) SEC 4/5/1

來函檔號 YOUR REF.:

Urgent By Fax (2869 6794) and By Post

Tel No. : 2810 3948  
Fax No. : 2868 9159

12 June 2006

Clerk to Public Works Subcommittee of Finance Committee  
Legislative Council Secretariat  
8 Jackson Road  
Central  
Hong Kong

(Attn: Mr. Paul WOO)

Dear Mr. Woo,

**Public Works Subcommittee of Finance Committee  
Follow-up to meeting on 29 May 2006**

**127BF – Fire Services Department diving training centre in the  
Government Dockyard at Stonecutters Island**

---


In considering PWSC(2006-07)16 on the above project on 29 May 2006, the Public Works Subcommittee (PWSC) requested the Administration to provide two-dimensional and/or cross-sectional plans on the facilities provided in the proposed diving training centre. Please find attached the requested sectional plans for circulation to Members before the Finance Committee to be held on 23 June 2006.

A handwritten signature in black ink, appearing to read 'Queenie Lee', written in a cursive style.

( Miss Queenie LEE )  
for Secretary for Security

c.c.

FSTB	(Attn: Miss Agnes YUEN)	Fax: 2147 5240
FSD	(Attn: Mr. CHEUNG Yin-chiu)	Fax: 2369 0941
ASD	(Attn: Mr. MAK Ka-chun)	Fax: 2804 6805

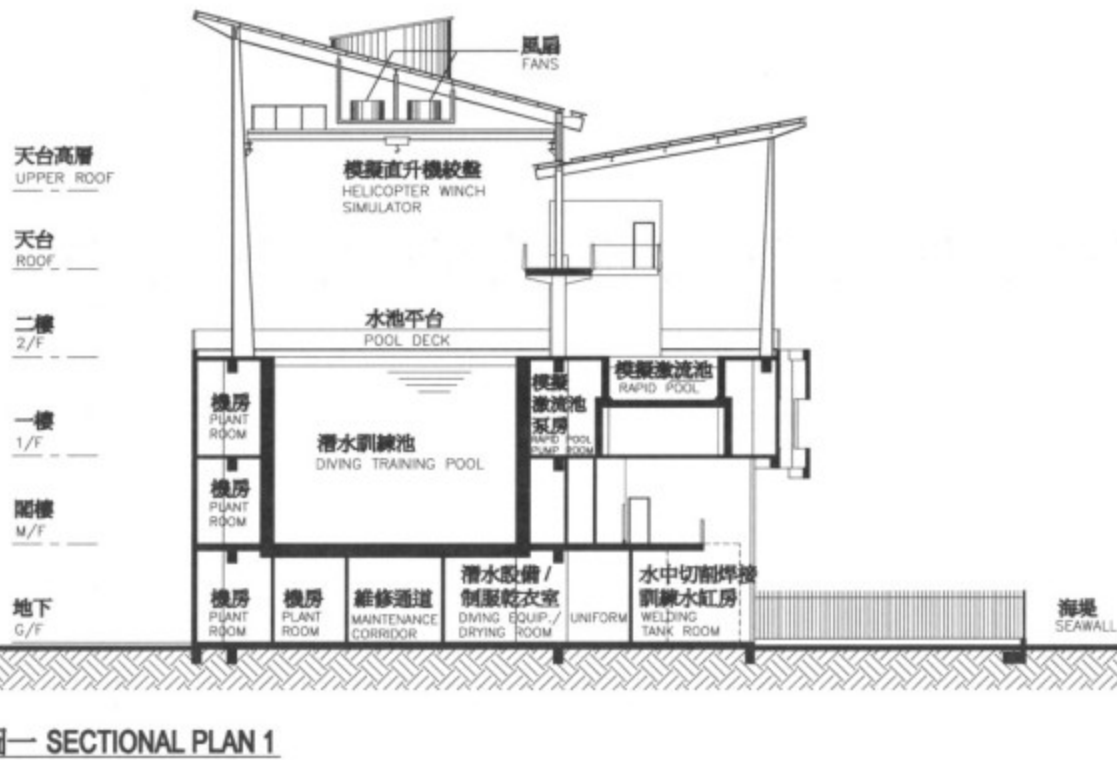

切面圖一 SECTIONAL PLAN 1



位置圖 KEY PLAN

比例 SCALE 1:1500

127BF  
昂船洲政府船塢消防處潛水訓練中心  
FIRE SERVICES DEPARTMENT DIVING TRAINING CENTRE IN THE  
GOVERNMENT DOCKYARD AT STONECUTTERS ISLAND

drawn by

J.L

date

06.06

drawing no.

AB/5970/XA101

scale

1:300

approved

T.H

date


06.06

office

PROJECT MANAGEMENT BRANCH



ARCHITECTURAL  
SERVICES  
DEPARTMENT

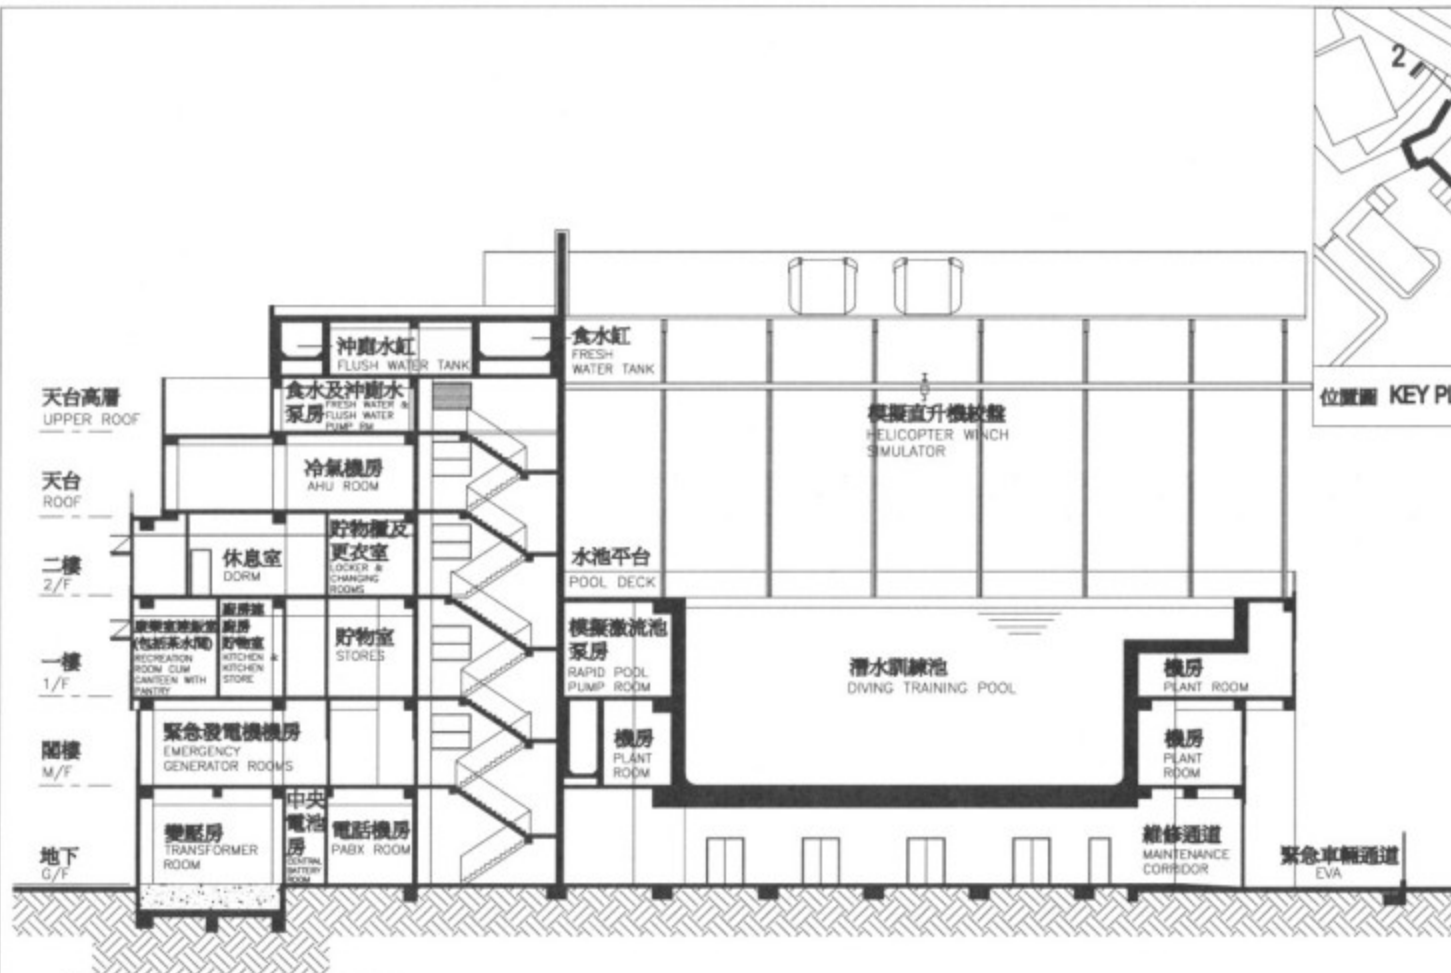

位置圖 KEY PLAN 比例 SCALE 1:1500

切面圖二 SECTIONAL PLAN 2

127BF  
 昂船洲政府船塢消防處潛水訓練中心  
 FIRE SERVICES DEPARTMENT DIVING TRAINING CENTRE IN THE  
 GOVERNMENT DOCKYARD AT STONECUTTERS ISLAND

drawn by	J.L.	date	06.06
approved	T.H.	date	06.06
office PROJECT MANAGEMENT BRANCH			

drawing no.	AB/5970/XA102	scale	1:300
		ARCHITECTURAL SERVICES DEPARTMENT	